


B1 PLAN
SCALE: 1" = 50'



A1 PROFILE
SCALE: 1" = 50'

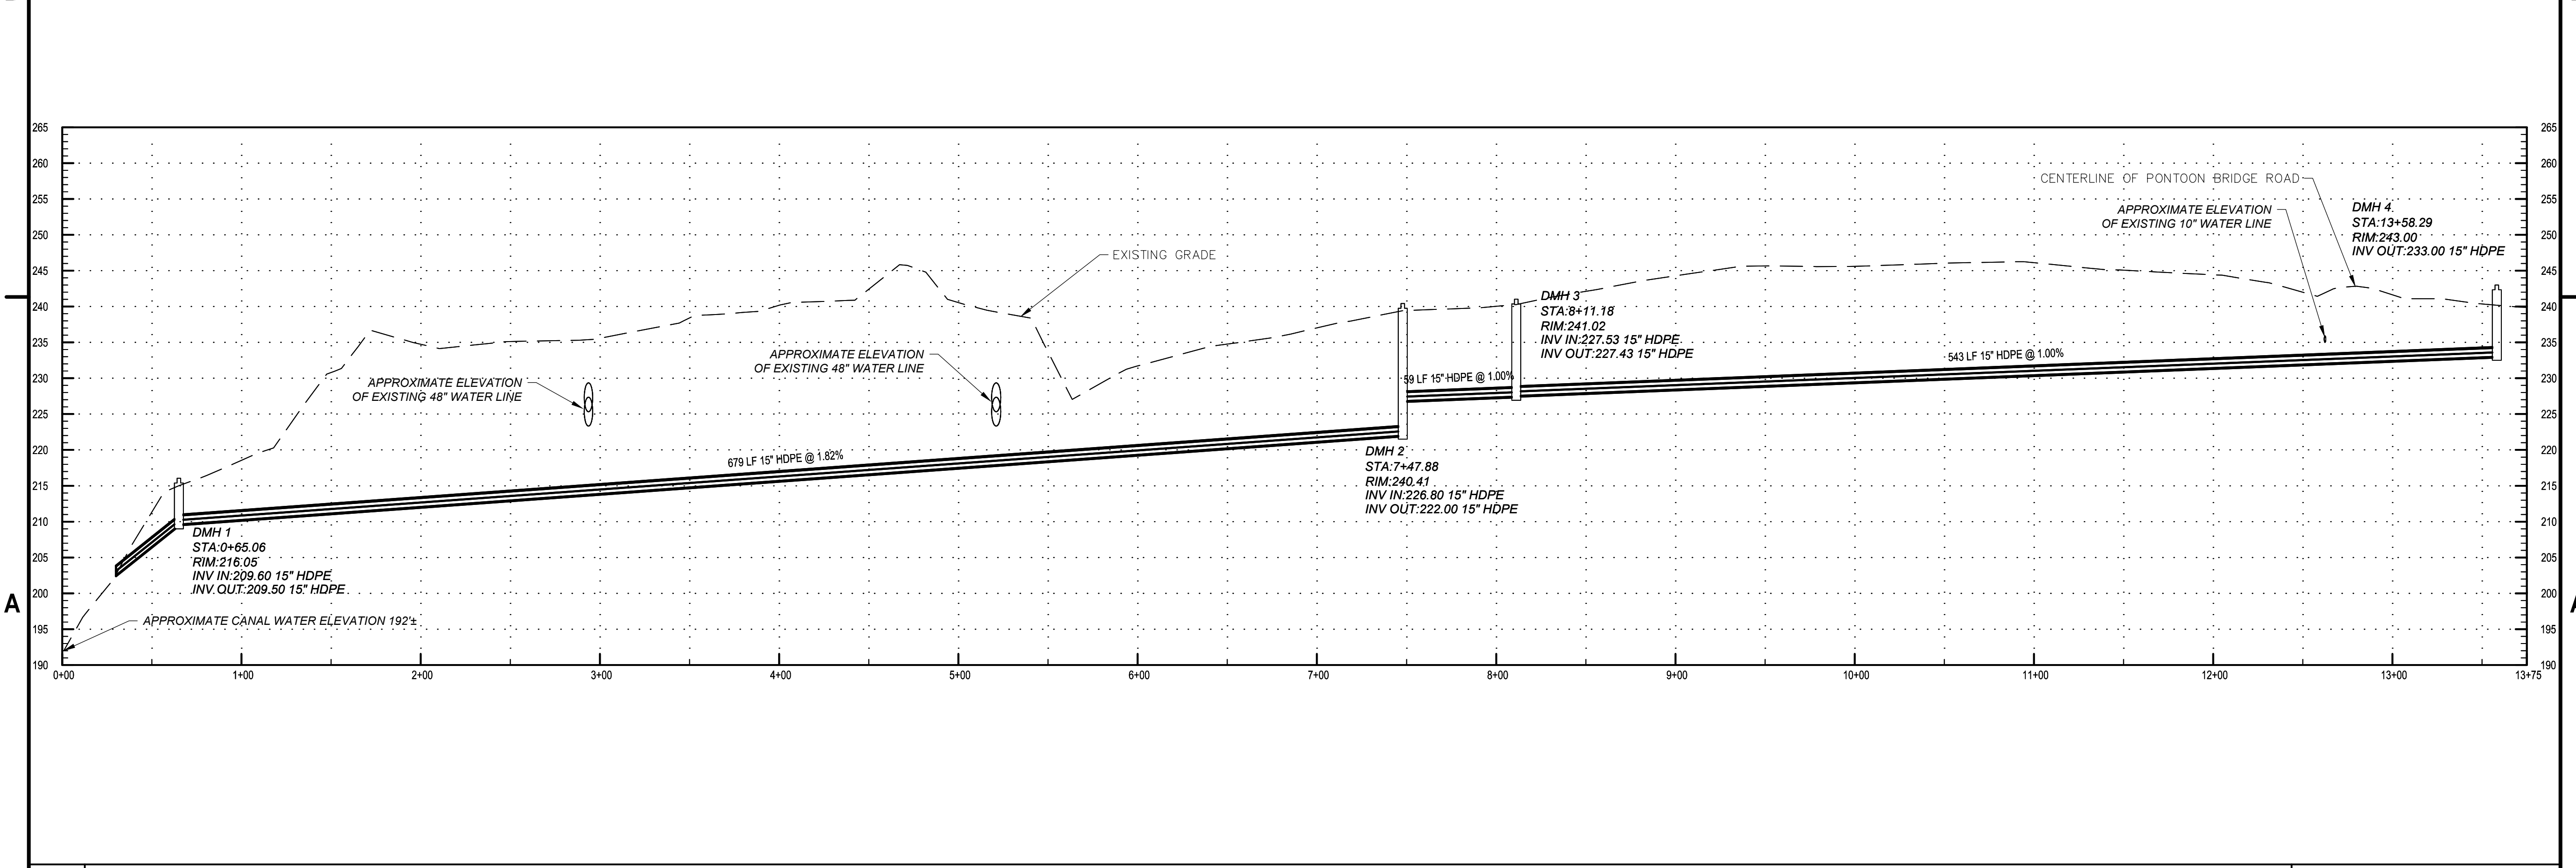

C&S Engineers, Inc.
499 Col. Eileen Collins Blvd.
Syracuse, New York 13212
Phone: 315-455-2000
Fax: 315-455-9667
www.cscos.com

PRELIMINARY
NOT FOR CONSTRUCTION



AIR PRODUCTS & CHEMICALS, INC.
MASSENA GREEN H2 PLANT
MASSENA, NEW YORK

MARK	DATE	DESCRIPTION
REVISIONS		
PROJECT NO: Z73.001.001		
DATE: FEBRUARY 2023		
DRAWN BY: M. MARCHEWKA		
DESIGNED BY:		
CHECKED BY:		

NO ALTERATION PERMITTED HEREON EXCEPT AS PROVIDED UNDER SECTION 7209 SUBDIVISION 2 OF THE NEW YORK EDUCATION LAW


DRAINAGE PLAN AND PROFILE OF 15" HDPE DRAINAGE LINE

CU-101


PRELIMINARY
NOT FOR CONSTRUCTION

AIR PRODUCTS


AIR PRODUCTS & CHEMICALS, INC.
MASSENA GREEN H2 PLANT
MASSENA, NEW YORK

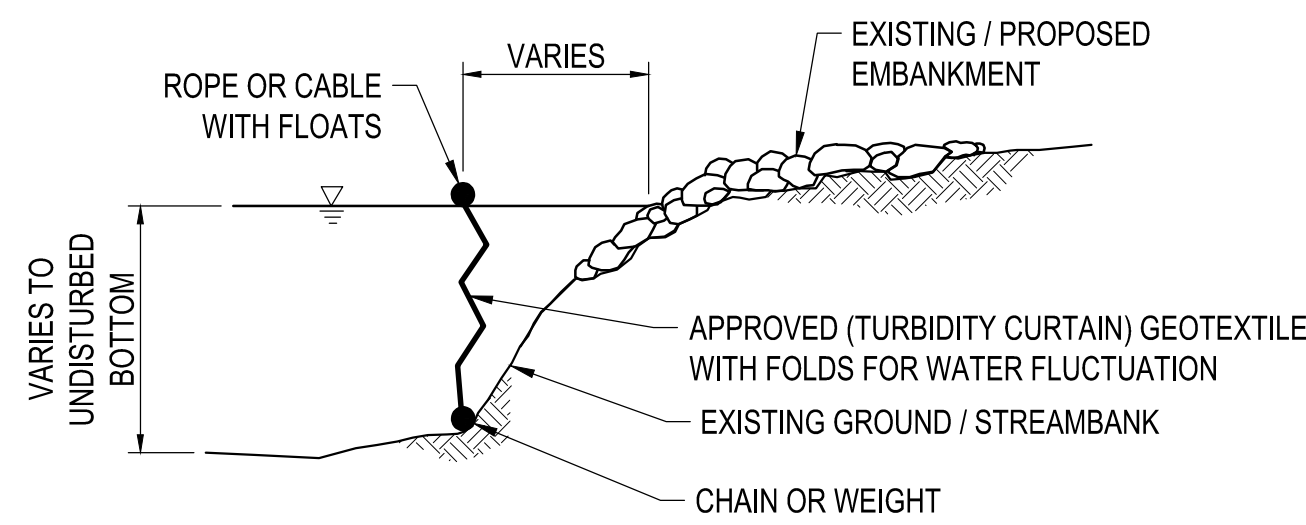


C1 TURBIDITY CURTAIN SECTION
SCALE: 1" = 1'-0"

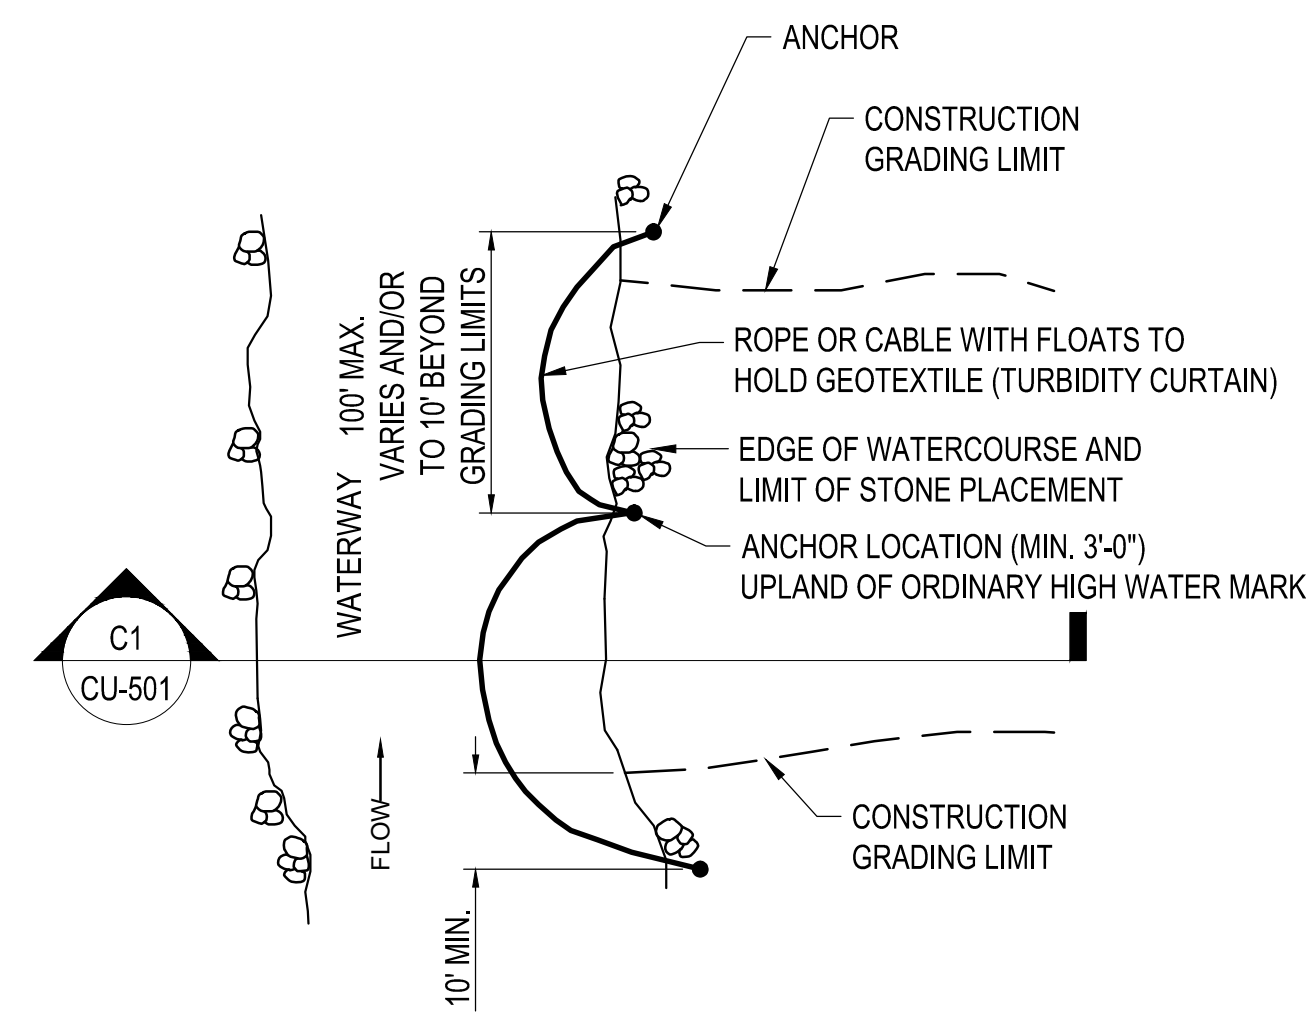


B1 TURBIDITY CURTAIN DETAIL
NOT TO SCALE

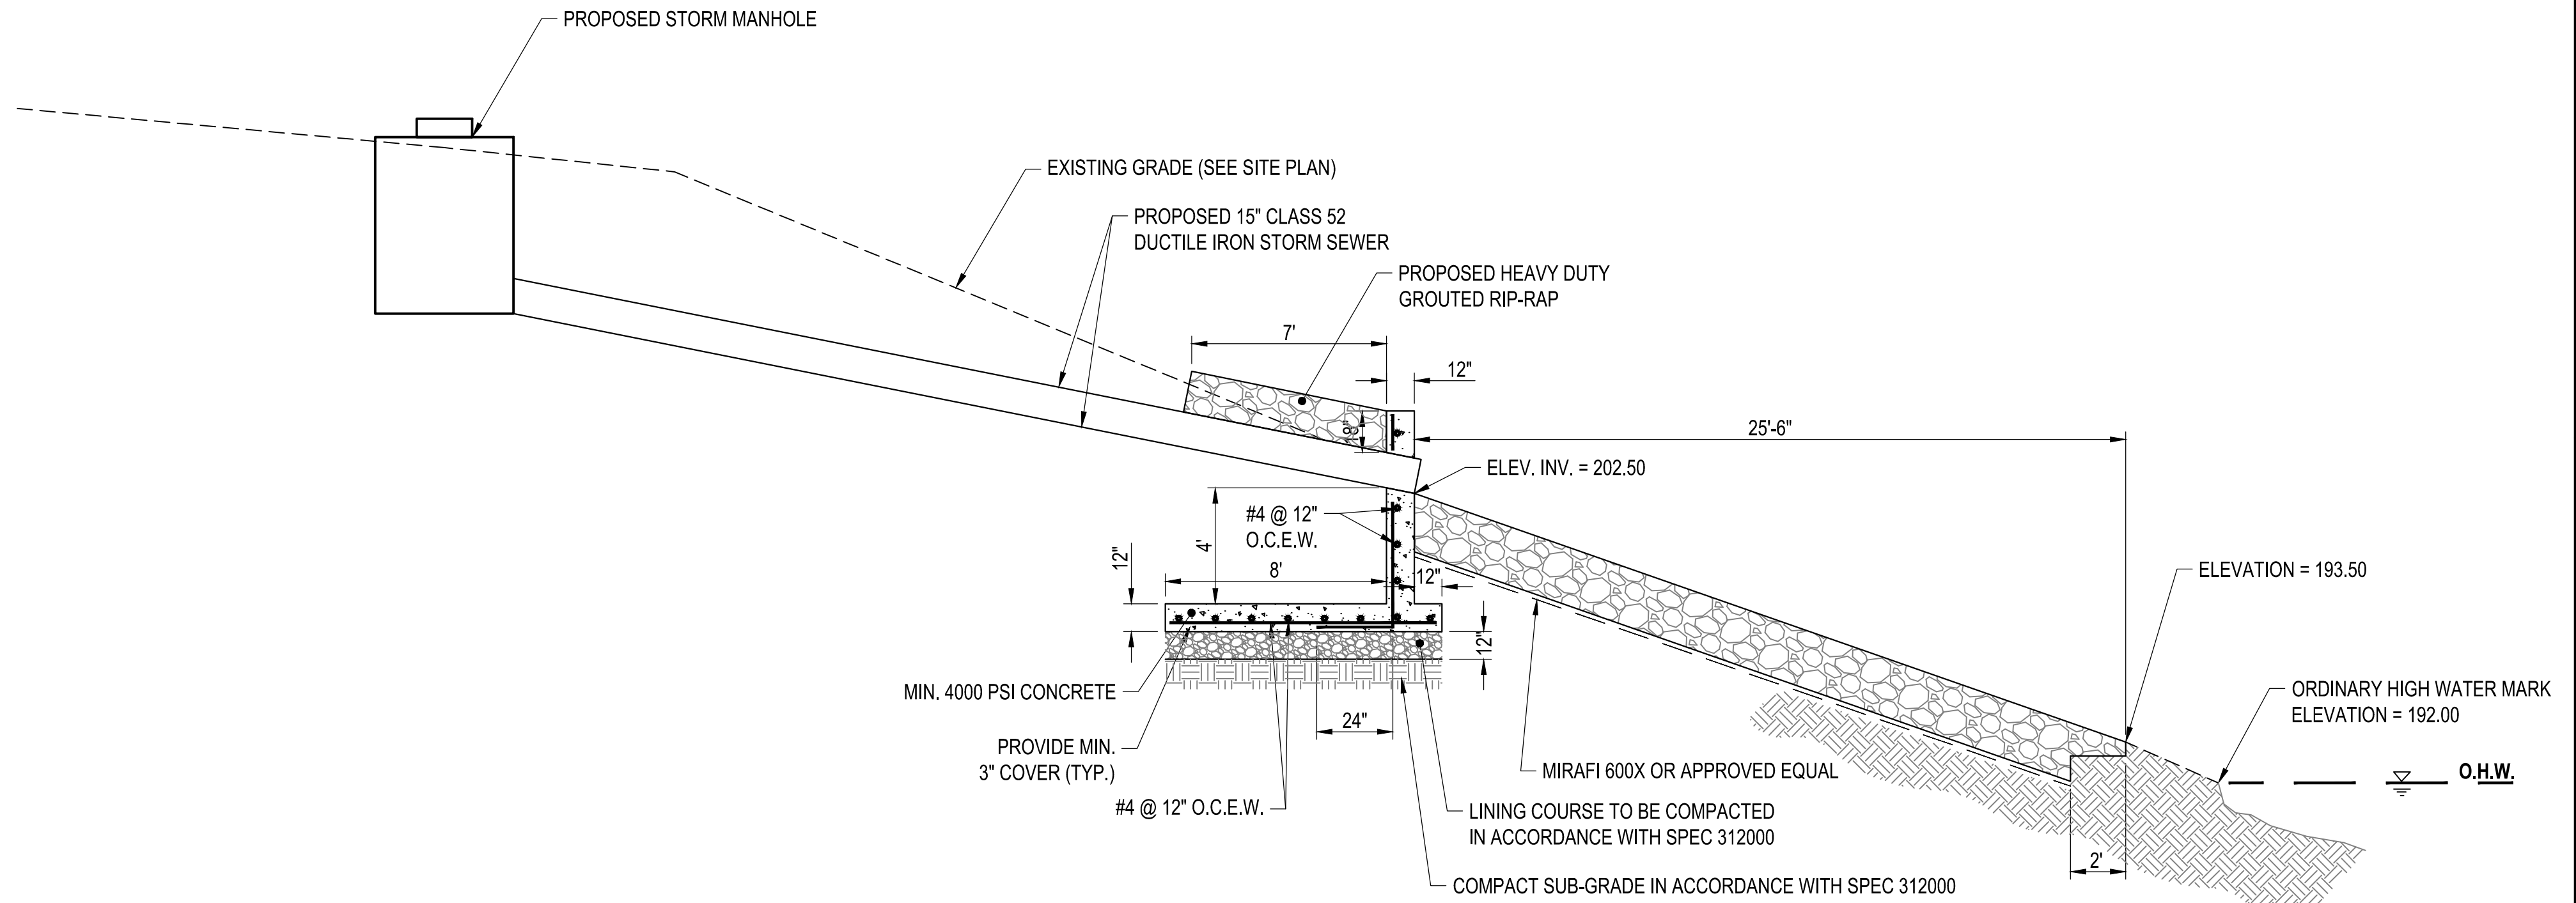

B2 CONCRETE HEAD WALL SECTION
NOT TO SCALE

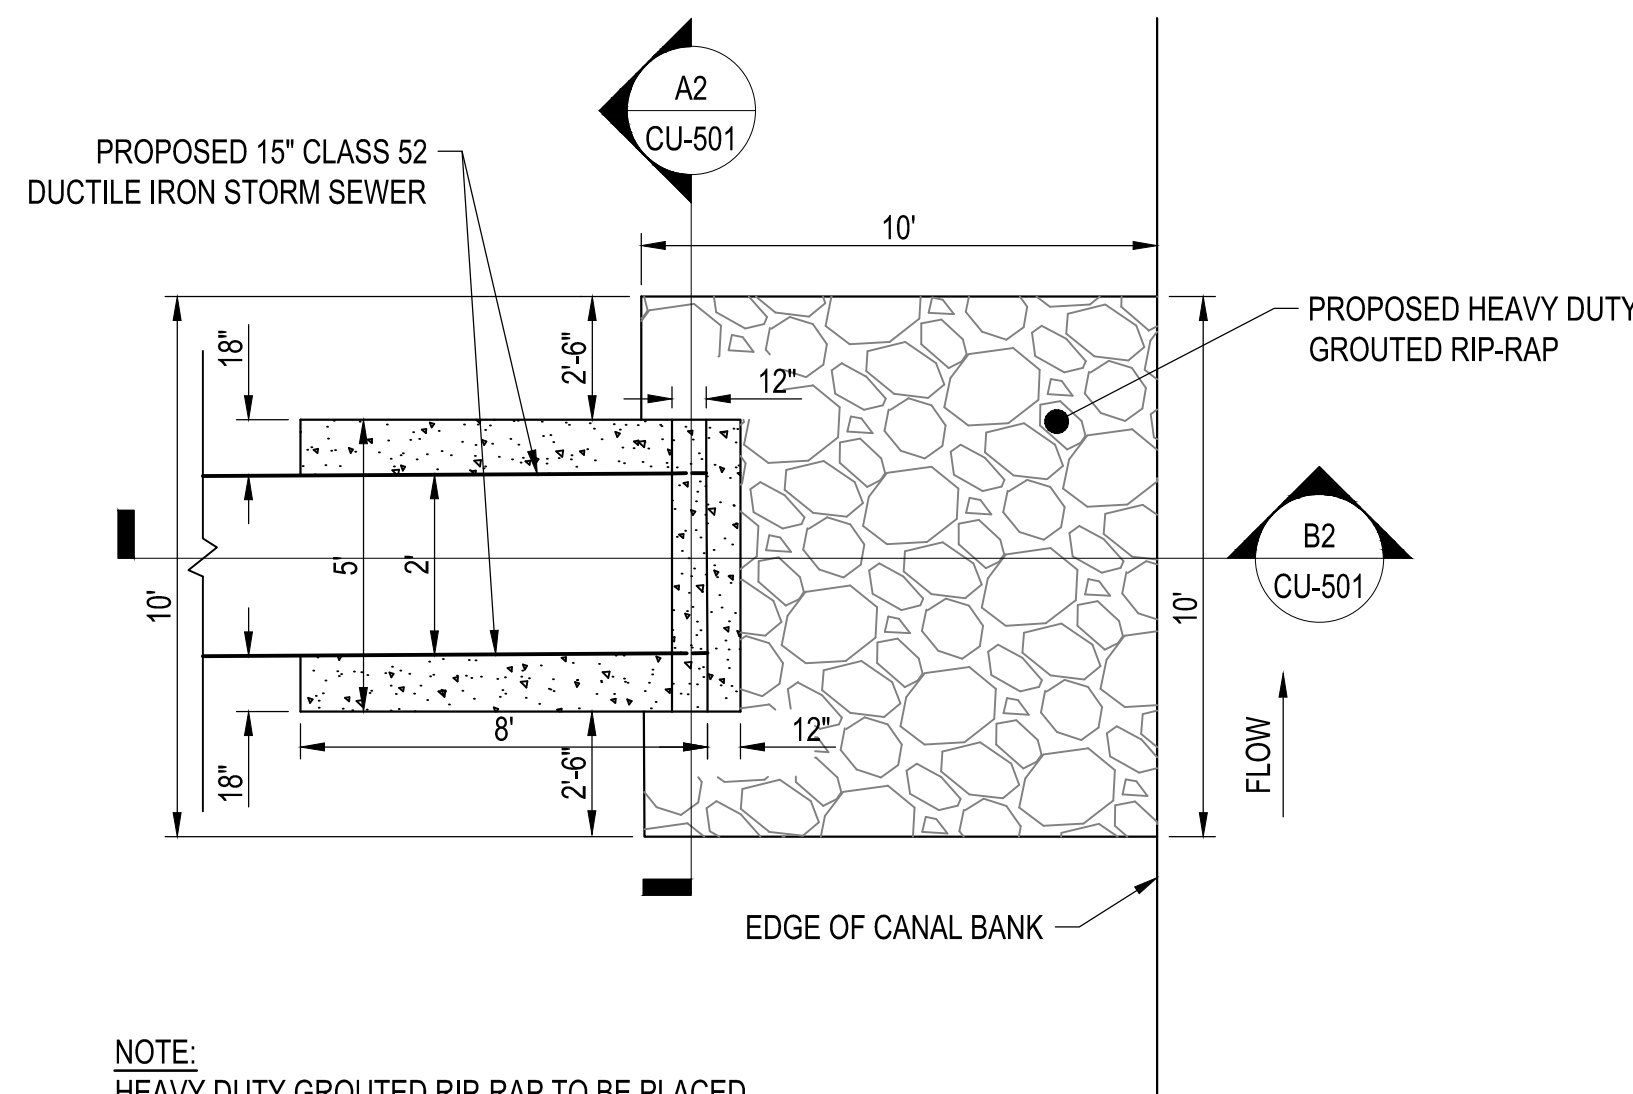

A1 CONCRETE HEADWALL DETAIL
NOT TO SCALE

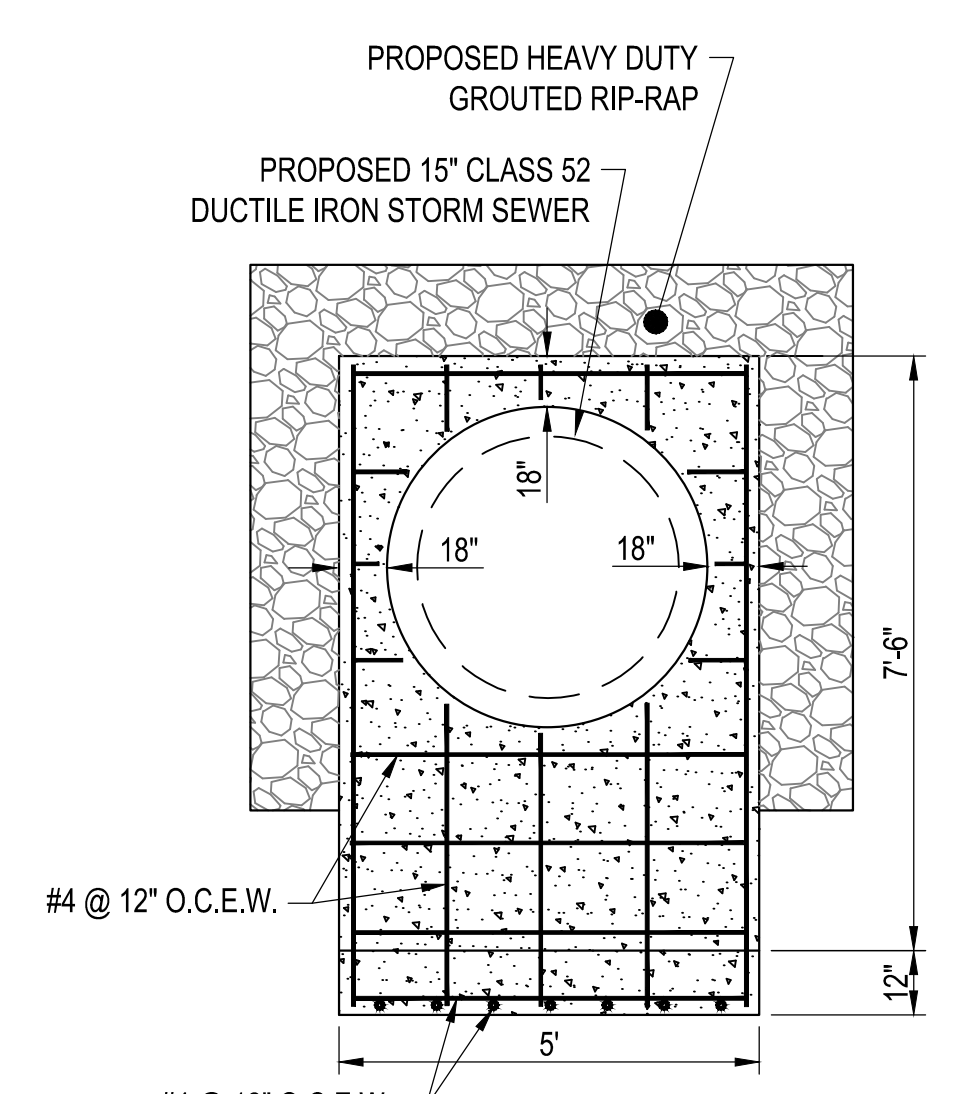

A2 CONCRETE HEAD WALL SECTION
NOT TO SCALE



A3 NOT USED
NOT TO SCALE



A4 NOT USED
NOT TO SCALE

MARK	DATE	DESCRIPTION
REVISIONS		
PROJECT NO: Z73.001.001		
DATE: FEBRUARY 2023		
DRAWN BY: M. MARCHEWKA		
DESIGNED BY:		
CHECKED BY:		
NO ALTERATION PERMITTED HEREON EXCEPT AS PROVIDED UNDER SECTION 7209 SUBDIVISION 2 OF THE NEW YORK EDUCATION LAW		

DETAILS

CU-501